


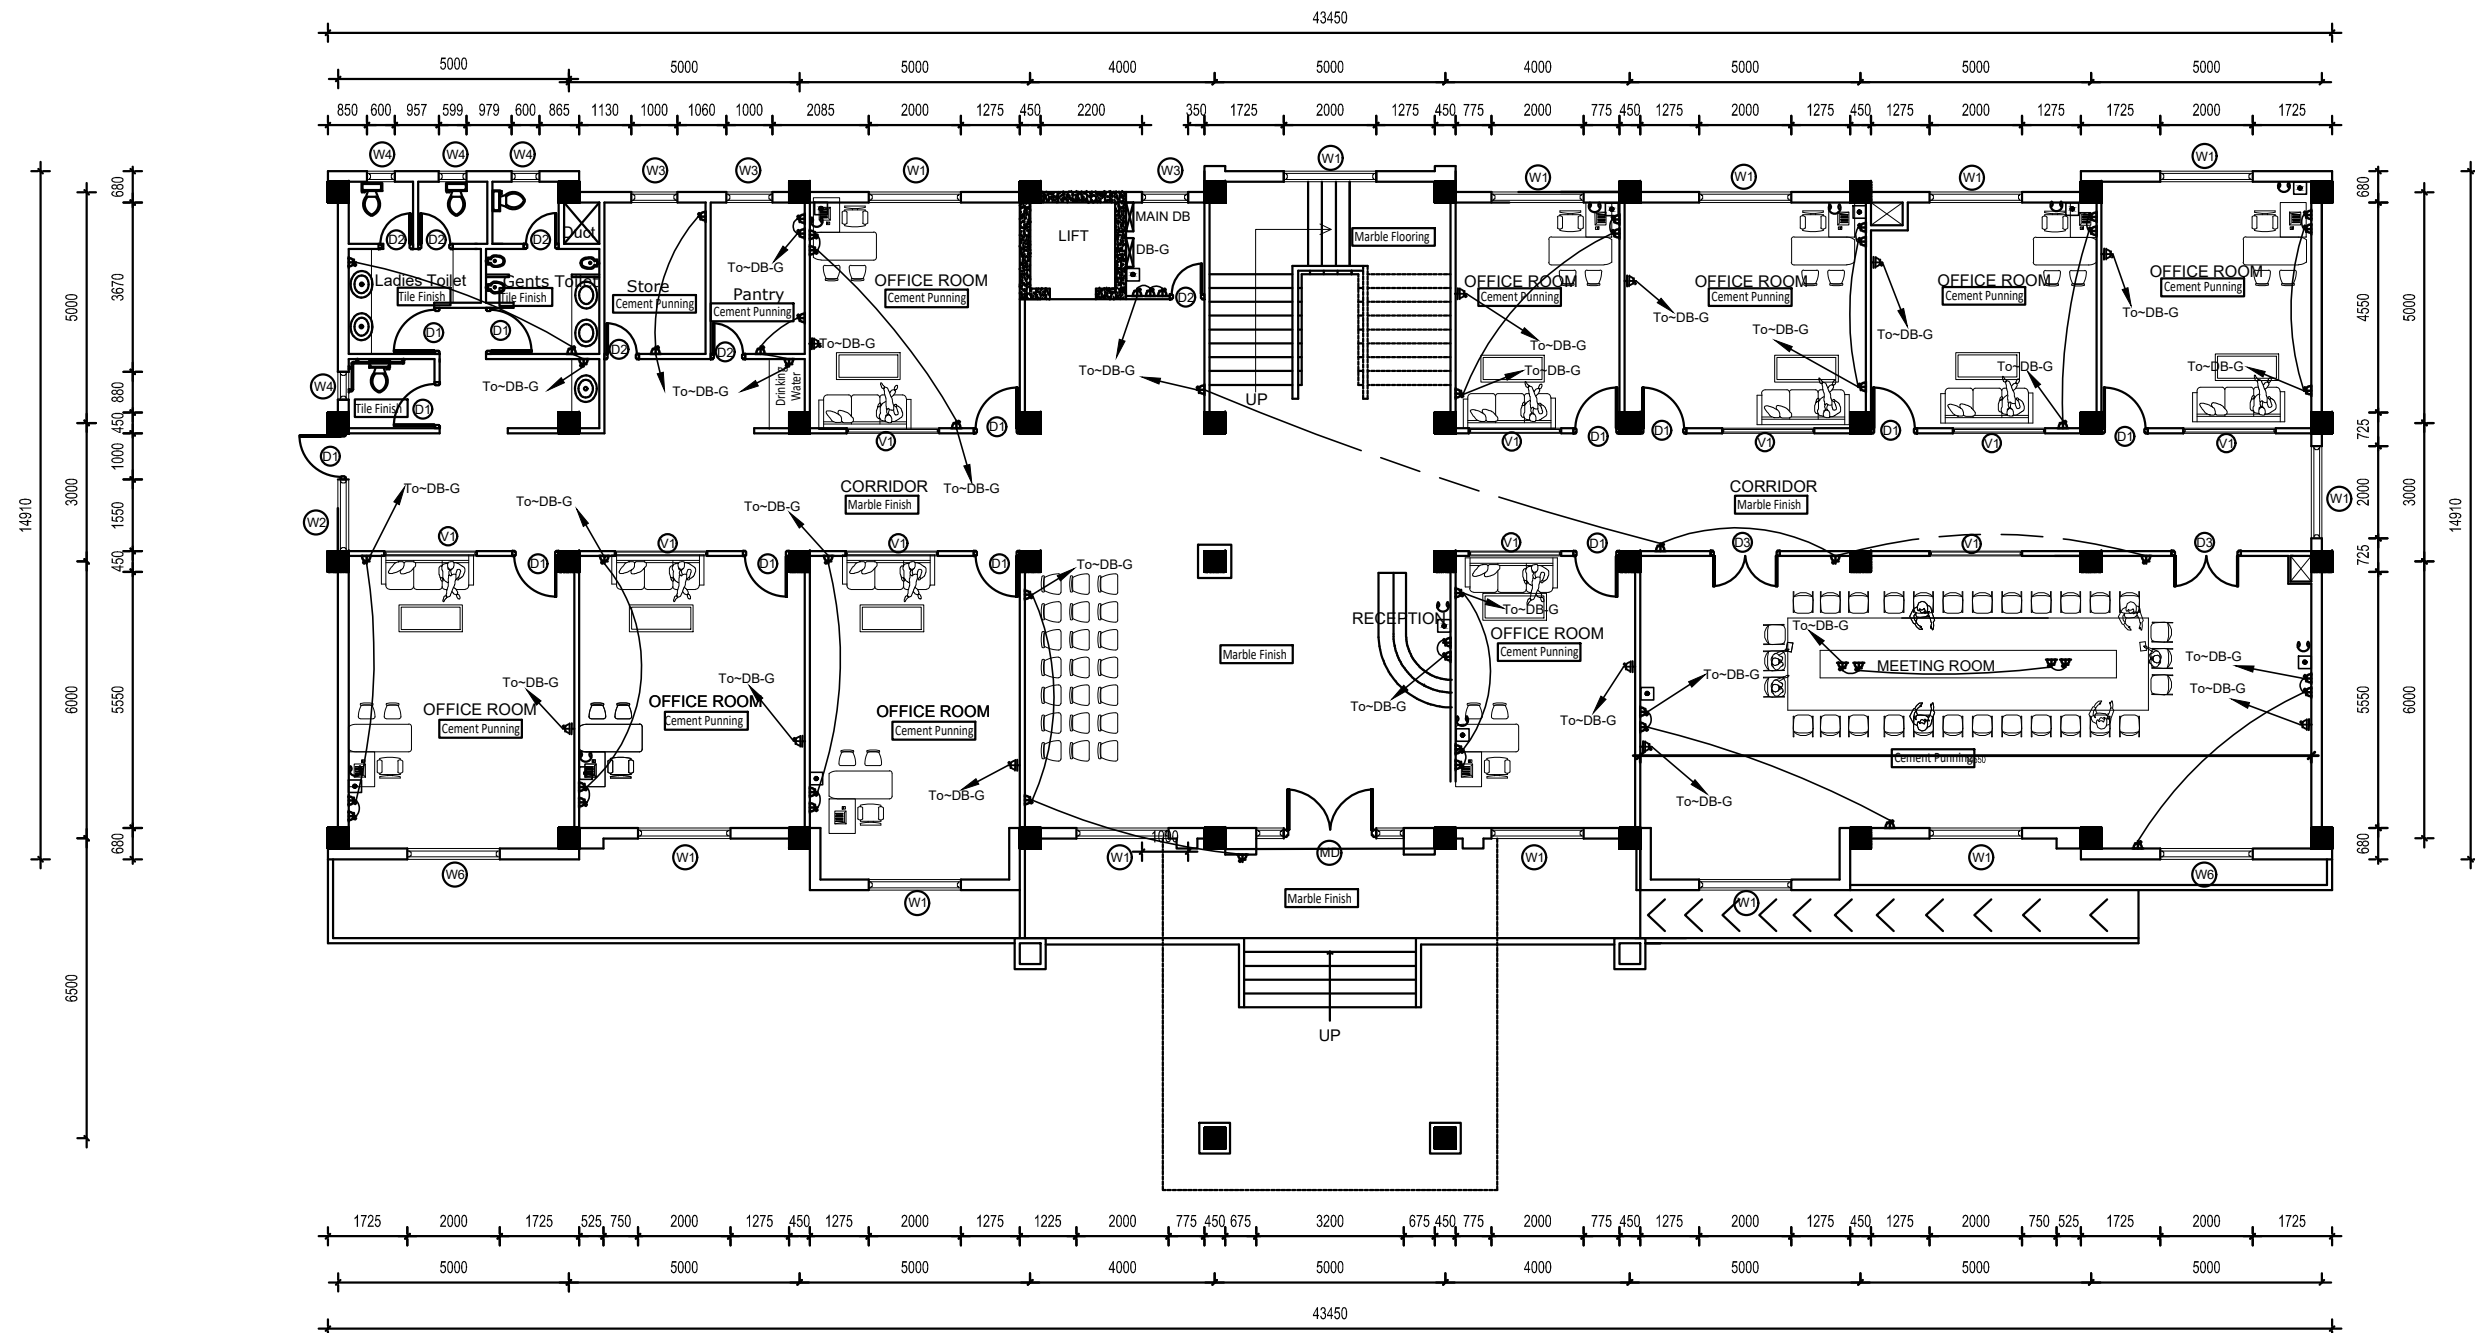

GROUND FLOOR PLAN
Area: 698.73 SQ.M.

Client :
Rautamai Rural Municipality
Office of the Municipal Executive
Bhutar, Udaypur
Province-1
Nepal

Consultant :
Gaumukhi Engineering Services Pvt.Ltd
Sanepa,Lalitpur-2, Nepal
Phone: 01-5905005
Email: gaumukhiengineering@gmail.com


Project Title:
Detailed Project Report of Municipality Building
Rautamai Rural Municipality, Bhutar, Udaypur

Consultant:
Designed By :
Signature :
Checked By :Mahan Ji Yadev
Signature :
Approved By :
Signature :

Drawn By :
Signature :
Recommended By :
Signature :
Approved By :
Signature :

Client:
Checked By :
Signature :
Recommended By :
Signature :
Approved By :
Signature :
Sheet Title:
POWER, LAN & TEL. LAYOUT PLAN OF
GROUND FLOOR PLAN
Date :2019
Scale : 1:150
Unit :Millimeter

Sheet No. :
E
01

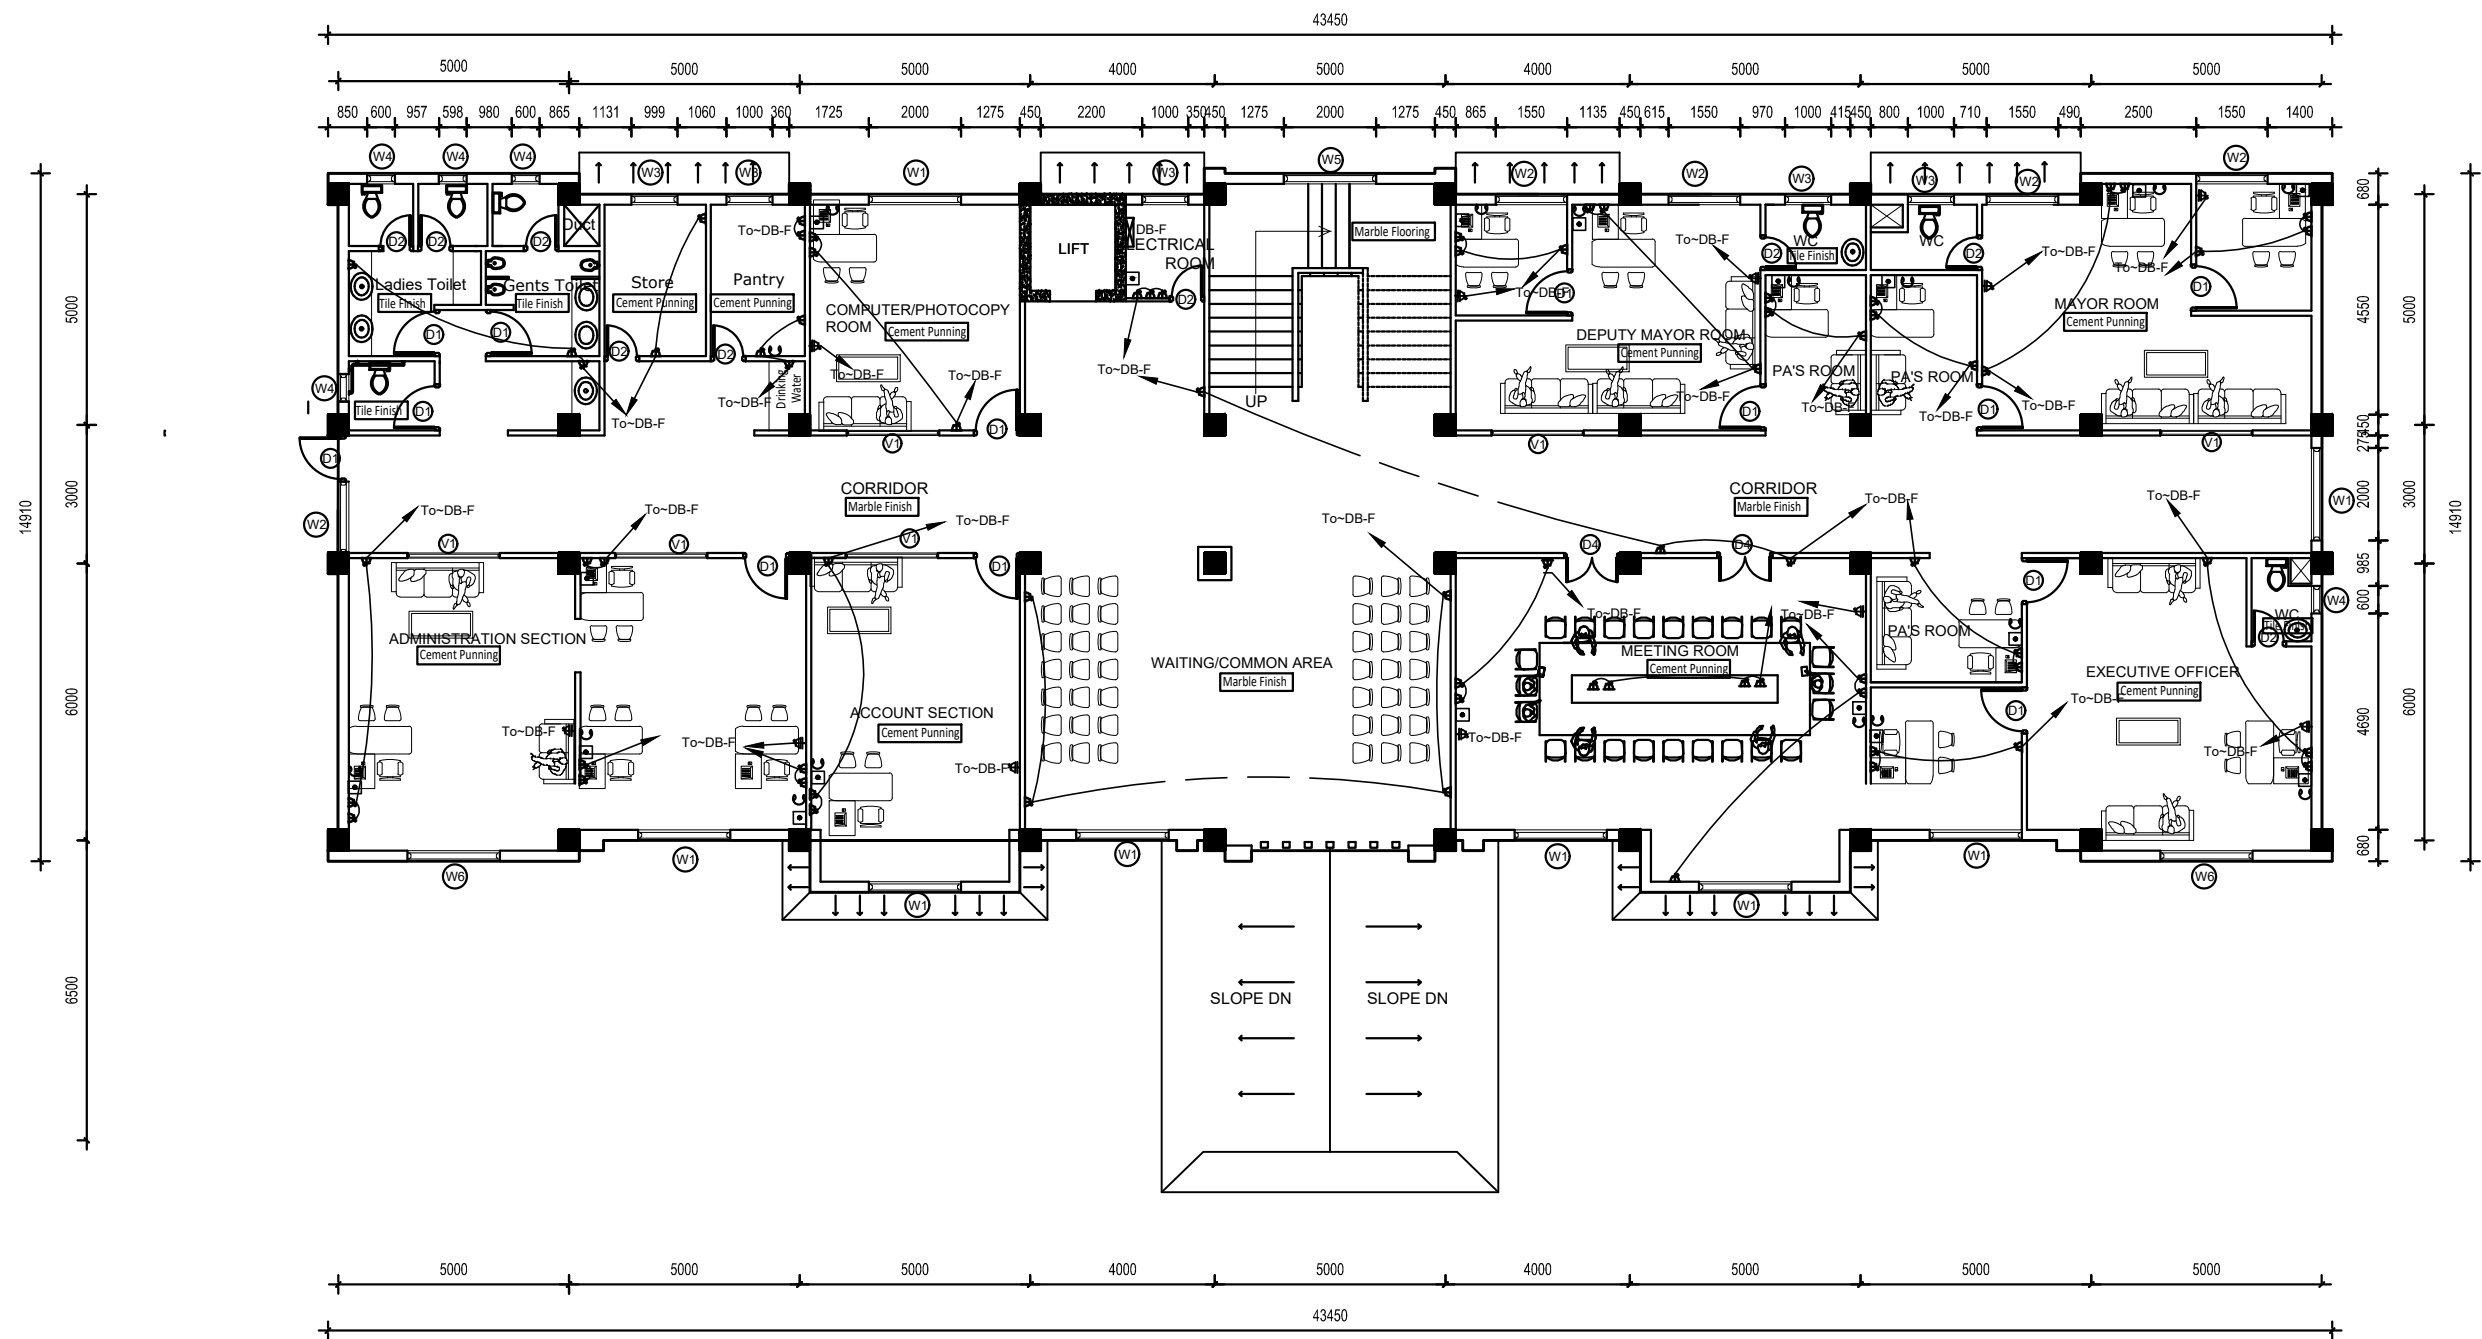

FIRST FLOOR PLAN
Area: 628.38 sq.m.

Client :
Rautamai Rural Municipality
Office of the Municipal Executive
Bhutar, Udaypur
Province-1
Nepal

Consultant :
Gaumukhi Engineering Services Pvt.Ltd
Sanepa,Lalitpur-2, Nepal
Phone: 01-5905005
Email: gaumukhiengineering@gmail.com

Project Title:
Detailed Project Report of Municipality Building
Rautamai Rural Municipality, Bhutar, Udaypur


Consultant:
Designed By :
Signature :
Checked By :Mahan Ji Yadev
Signature :
Approved By :
Signature :

Drawn By :
Signature :
Recommended By :
Signature :
Approved By :
Signature :

Client:
Checked By :
Signature :
Recommended By :
Signature :
Approved By :
Signature :

Sheet Title:
POWER, LAN & TEL. LAYOUT PLAN OF
FIRST FLOOR PLAN
Date :2019
Scale : 1:150
Unit :Millimeter

Sheet No. :
E
02

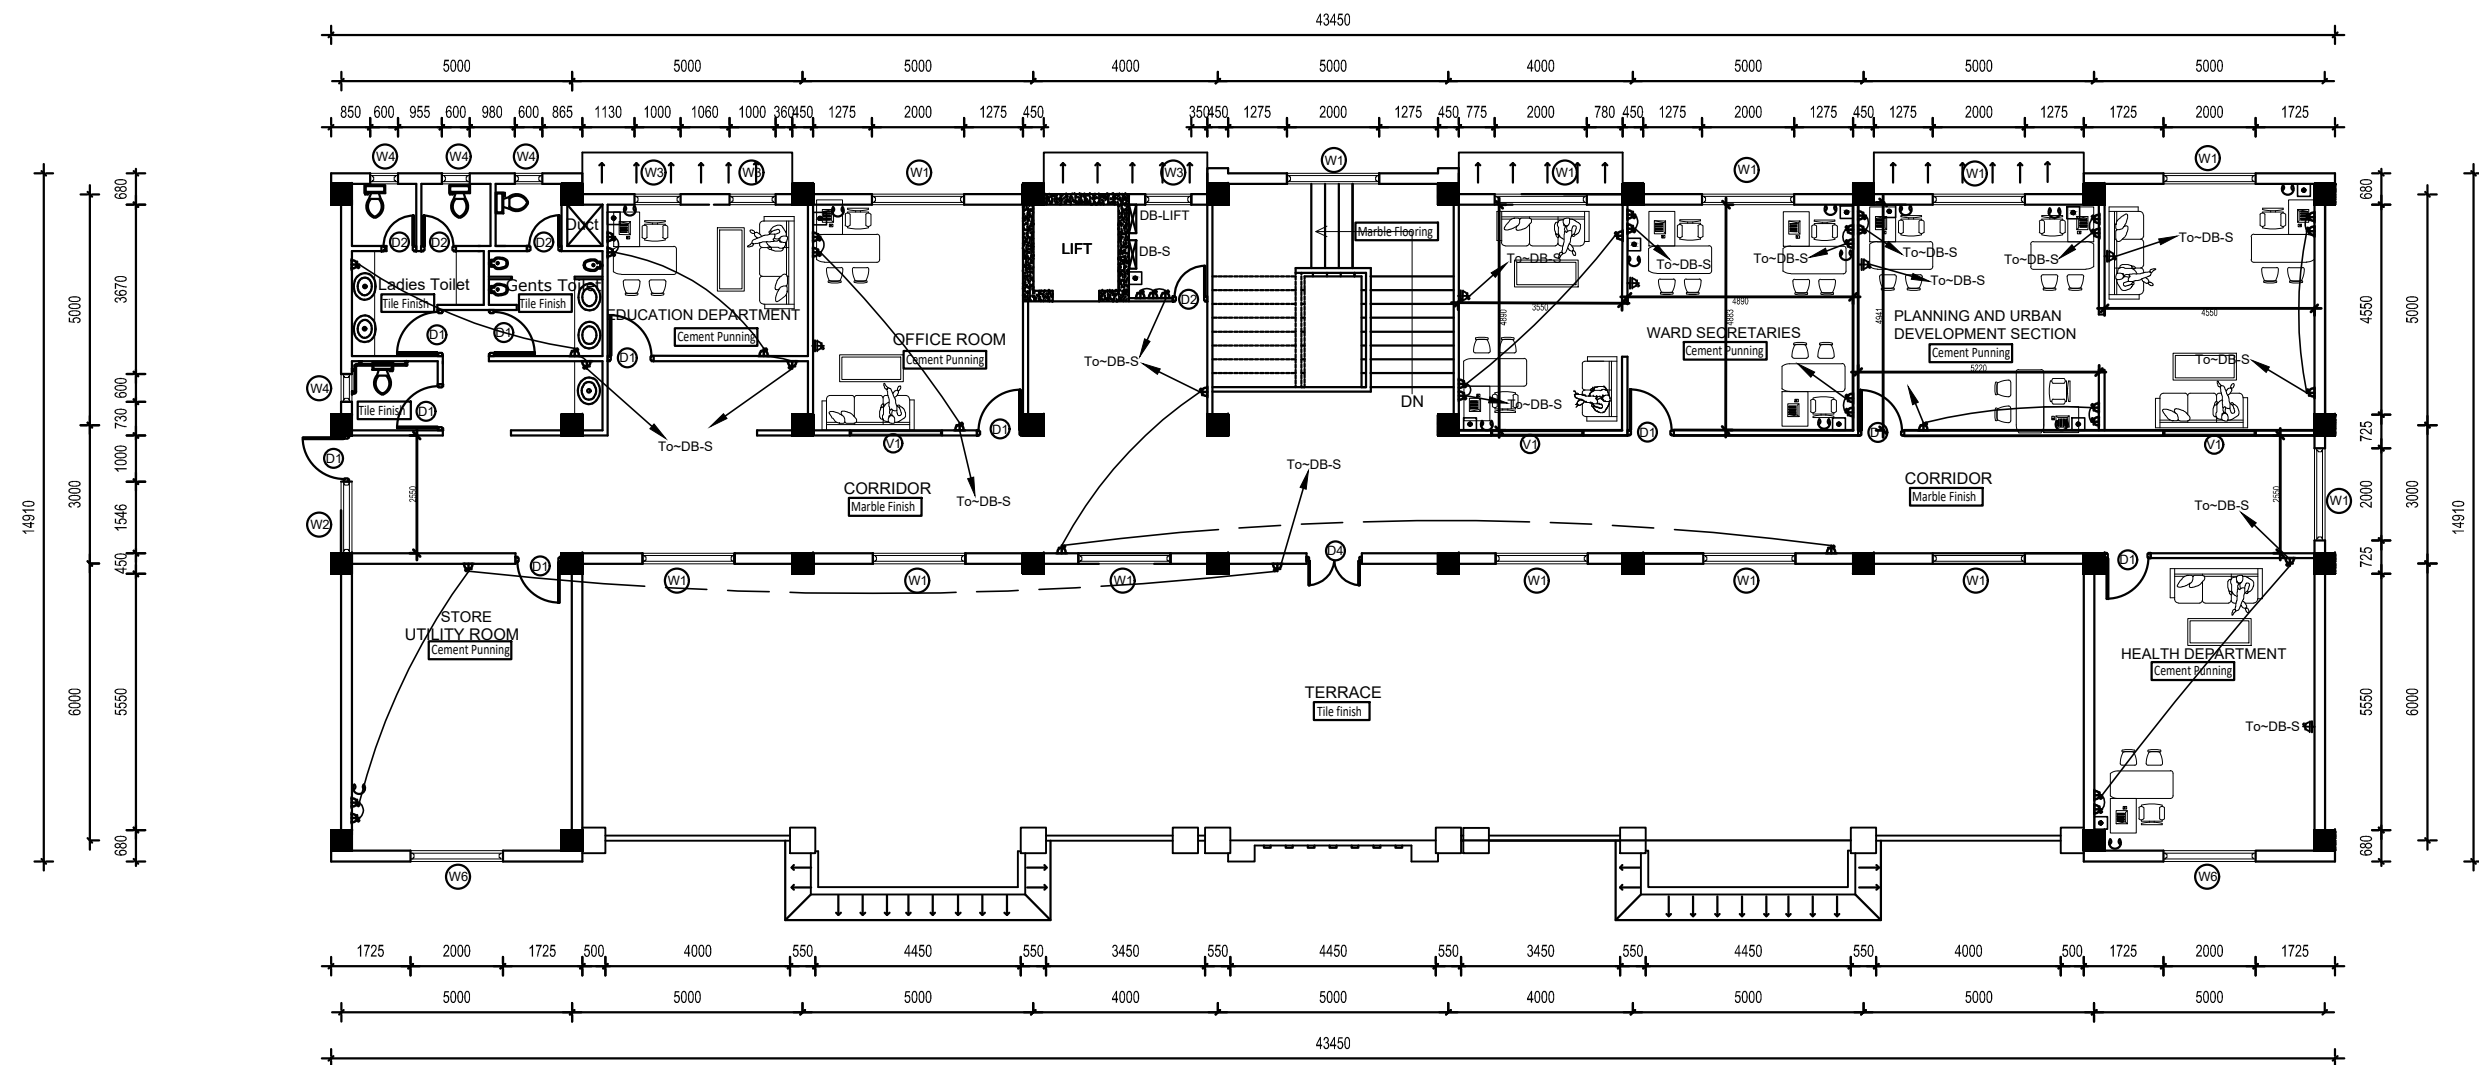

TOP FLOOR PLAN
Area: 421.20 SQ.M.

Client :
Rautamai Rural Municipality
Office of the Municipal Executive
Bhutar, Udaypur
Province-1
Nepal

Consultant :
Gaumukhi Engineering Services Pvt.Ltd
Sanepa,Lalitpur-2, Nepal
Phone: 01-5905005
Email: gaumukhiengineering@gmail.com

Project Title:
Detailed Project Report of Municipality Building
Rautamai Rural Municipality, Bhutar, Udaypur

Consultant:

Designed By : -

Signature :

Checked By :Mahan Ji Yadev

Signature :

Approved By :

Signature :

Drawn By :

Client:

Checked By :

Signature :

Recommended By :

Signature :

Approved By :

Signature :

Sheet Title:

POWER, LAN & TEL. LAYOUT PLAN OF
TOP FLOOR PLAN


Date :2019

Scale : 1:150

Unit :Millimeter

Sheet No. :

E
03

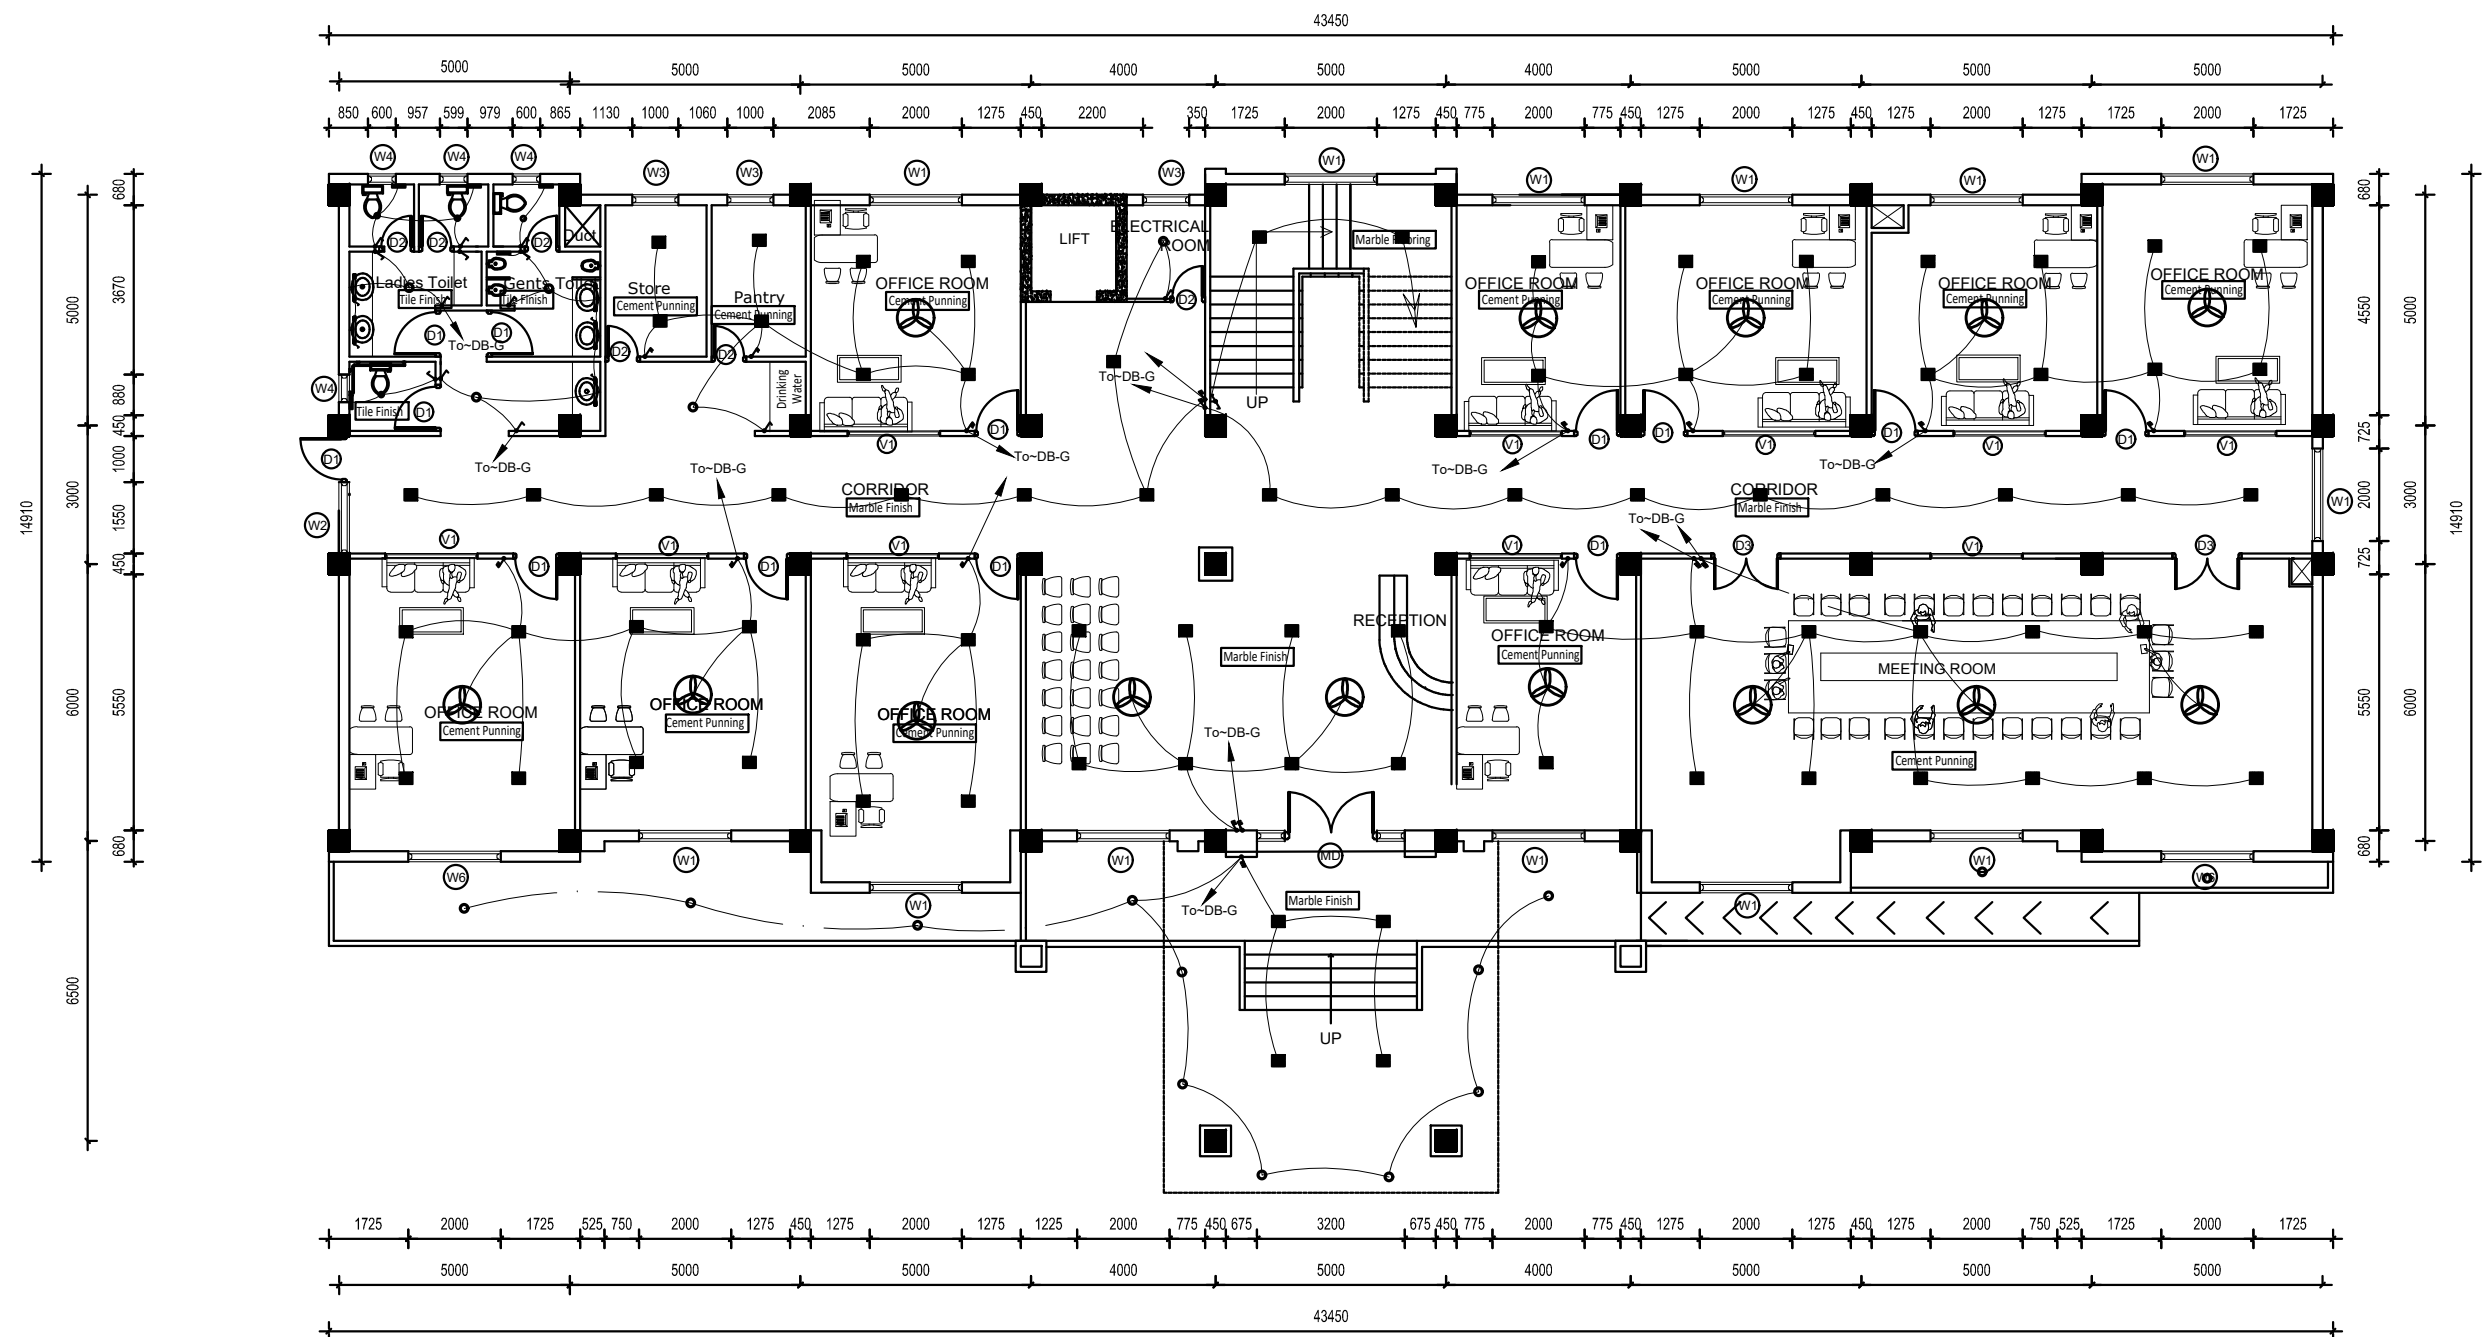

GROUND FLOOR PLAN
Area: 698.73 SQ.M.

Client :
Rautamai Rural Municipality
Office of the Municipal Executive
Bhutar, Udaypur
Province-1
Nepal

Consultant :
Gaumukhi Engineering Services Pvt.Ltd
Sanepa,Lalitpur-2, Nepal
Phone: 01-5905005
Email: gaumukhiengineering@gmail.com

Project Title:
Detailed Project Report of Municipality Building
Rautamai Rural Municipality, Bhutar, Udaypur


Consultant:
Designed By :
Signature :
Checked By :Mahan Ji Yadev
Signature :
Approved By :
Signature :

Drawn By :
Signature :
Recommended By :
Signature :
Approved By :
Signature :

Client:
Checked By :
Signature :
Recommended By :
Signature :
Approved By :
Signature :
Date :2019
Scale : 1:150
Unit :Millimeter

Sheet No. :

E
04

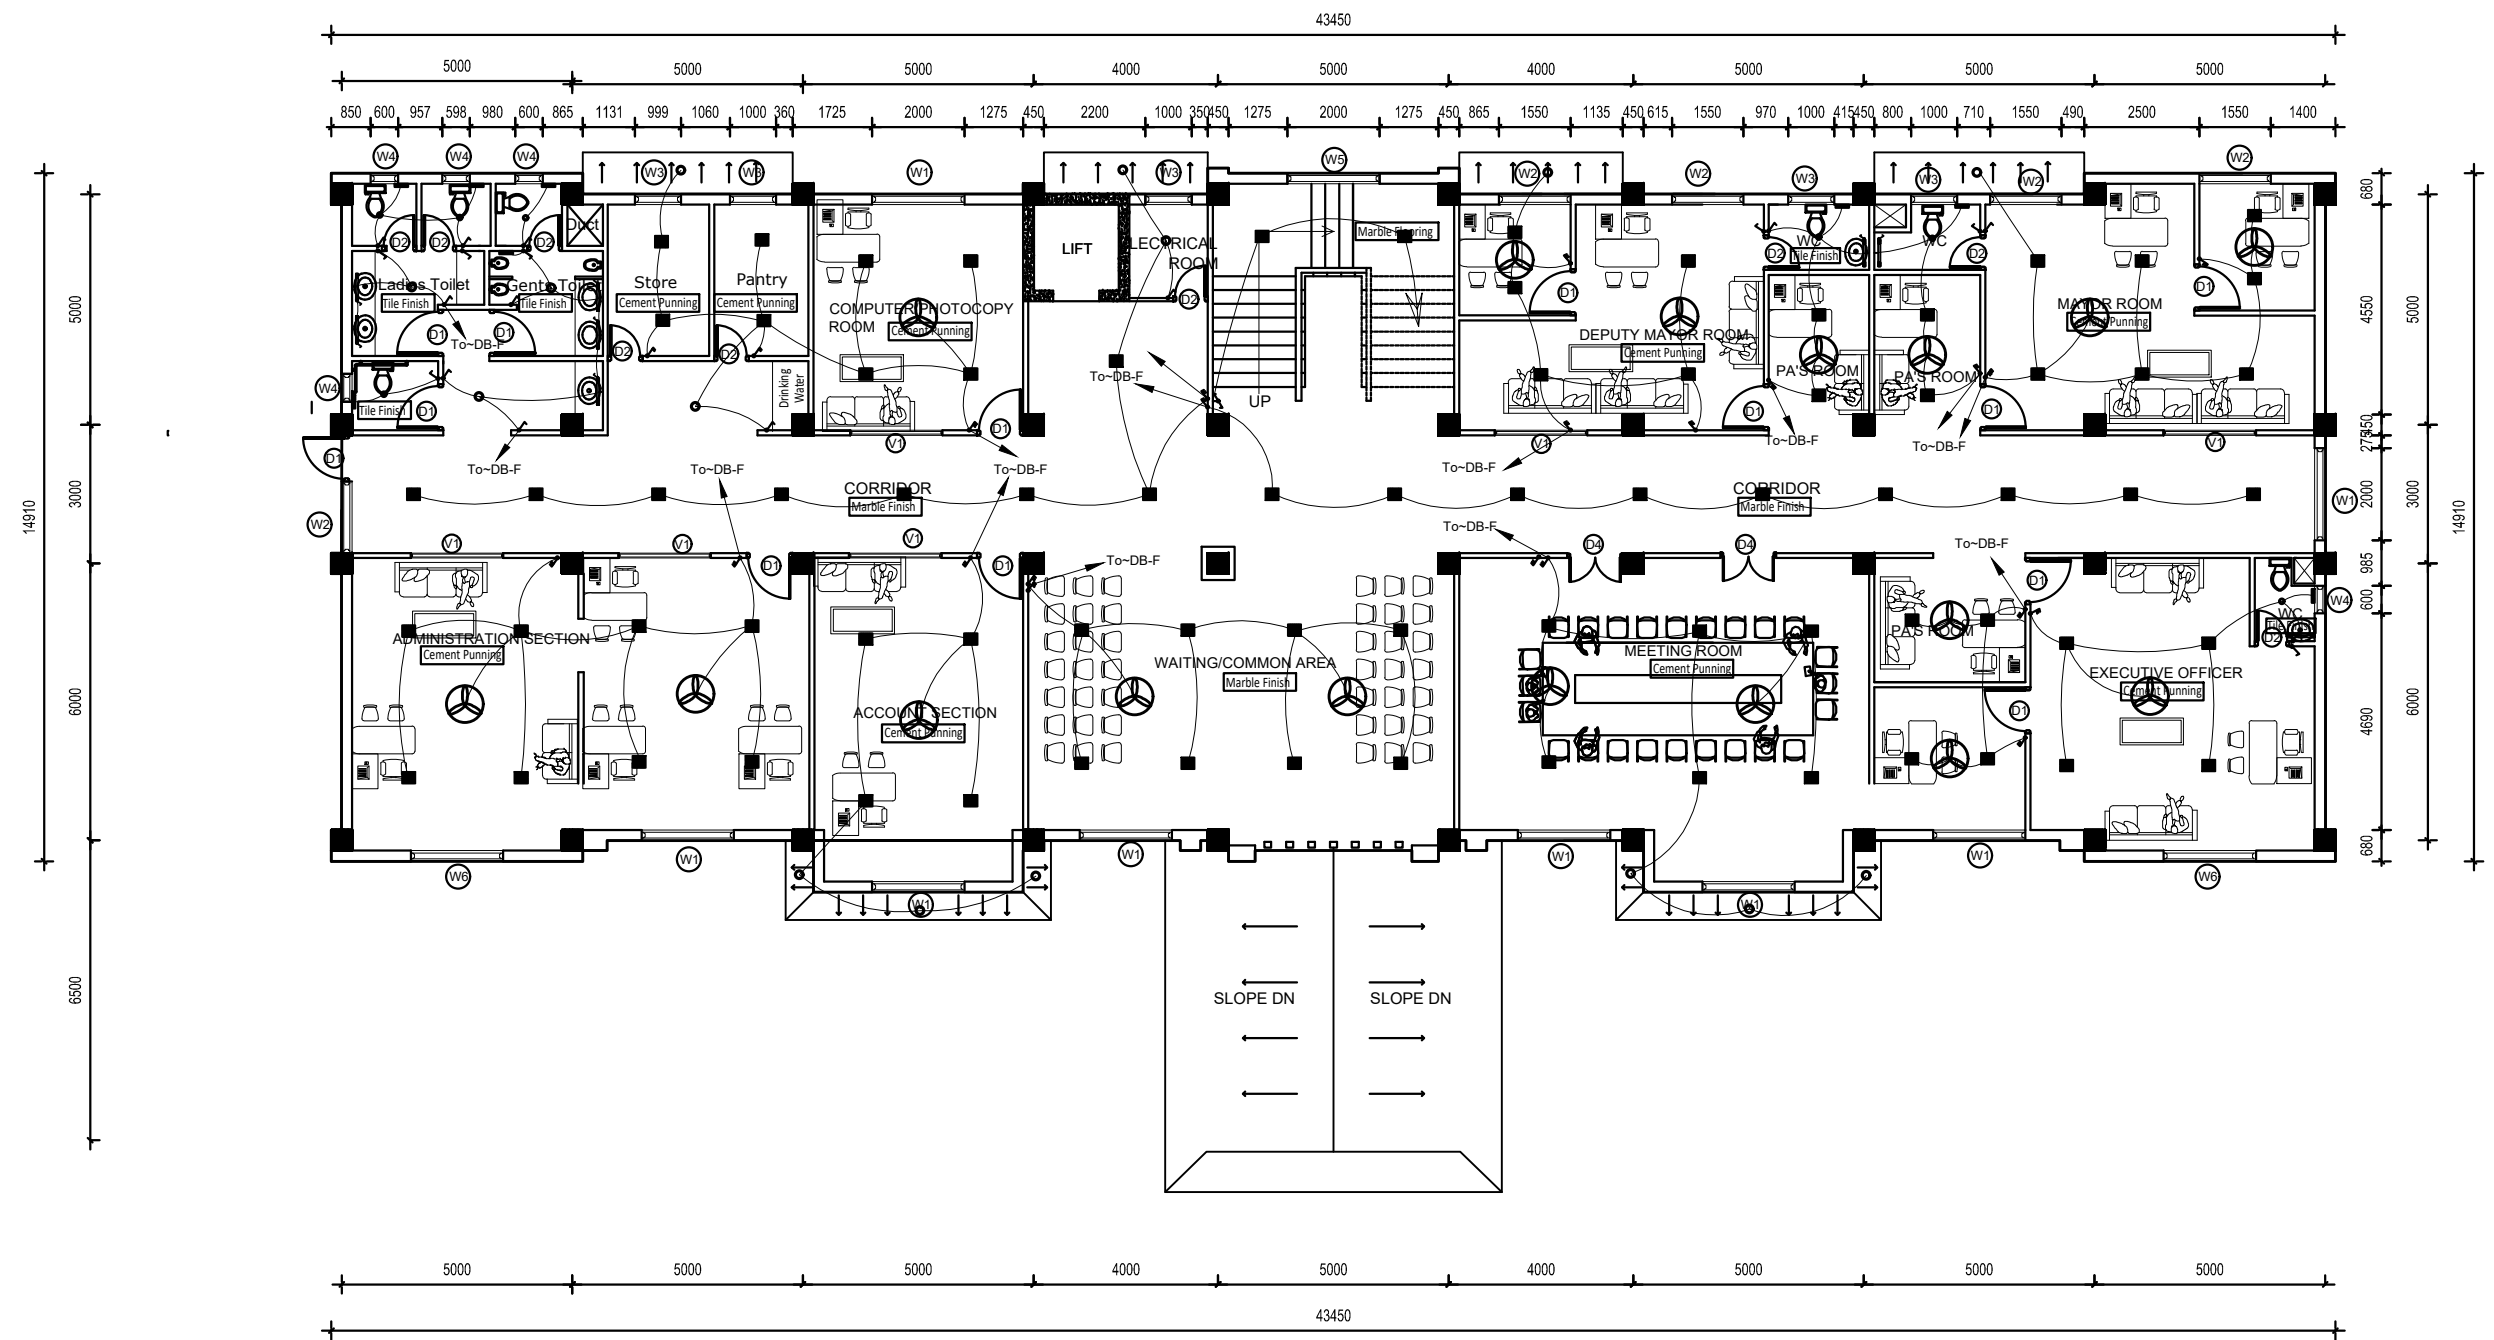

FIRST FLOOR PLAN
Area: 628.38 sq.m.

Client :
Rautamai Rural Municipality
Office of the Municipal Executive
Bhutar, Udaypur
Province-1
Nepal

Consultant :
Gaumukhi Engineering Services Pvt.Ltd
Sanepa,Lalitpur-2, Nepal
Phone: 01-5905005
Email: gaumukhiengineering@gmail.com

Project Title:
Detailed Project Report of Municipality Building
Rautamai Rural Municipality, Bhutar, Udaypur

Consultant:
Designed By :
Signature :
Checked By :Mahan Ji Yadev
Signature :
Approved By :
Signature :


Drawn By :

Client:
Checked By :
Signature :
Recommended By :
Signature :
Approved By :
Signature :

Sheet Title:
LIGHT LAYOUT PLAN OF FIRST FLOOR
PLAN
Date :2019
Scale : 1:150
Unit :Millimeter

Sheet No. :

E
05

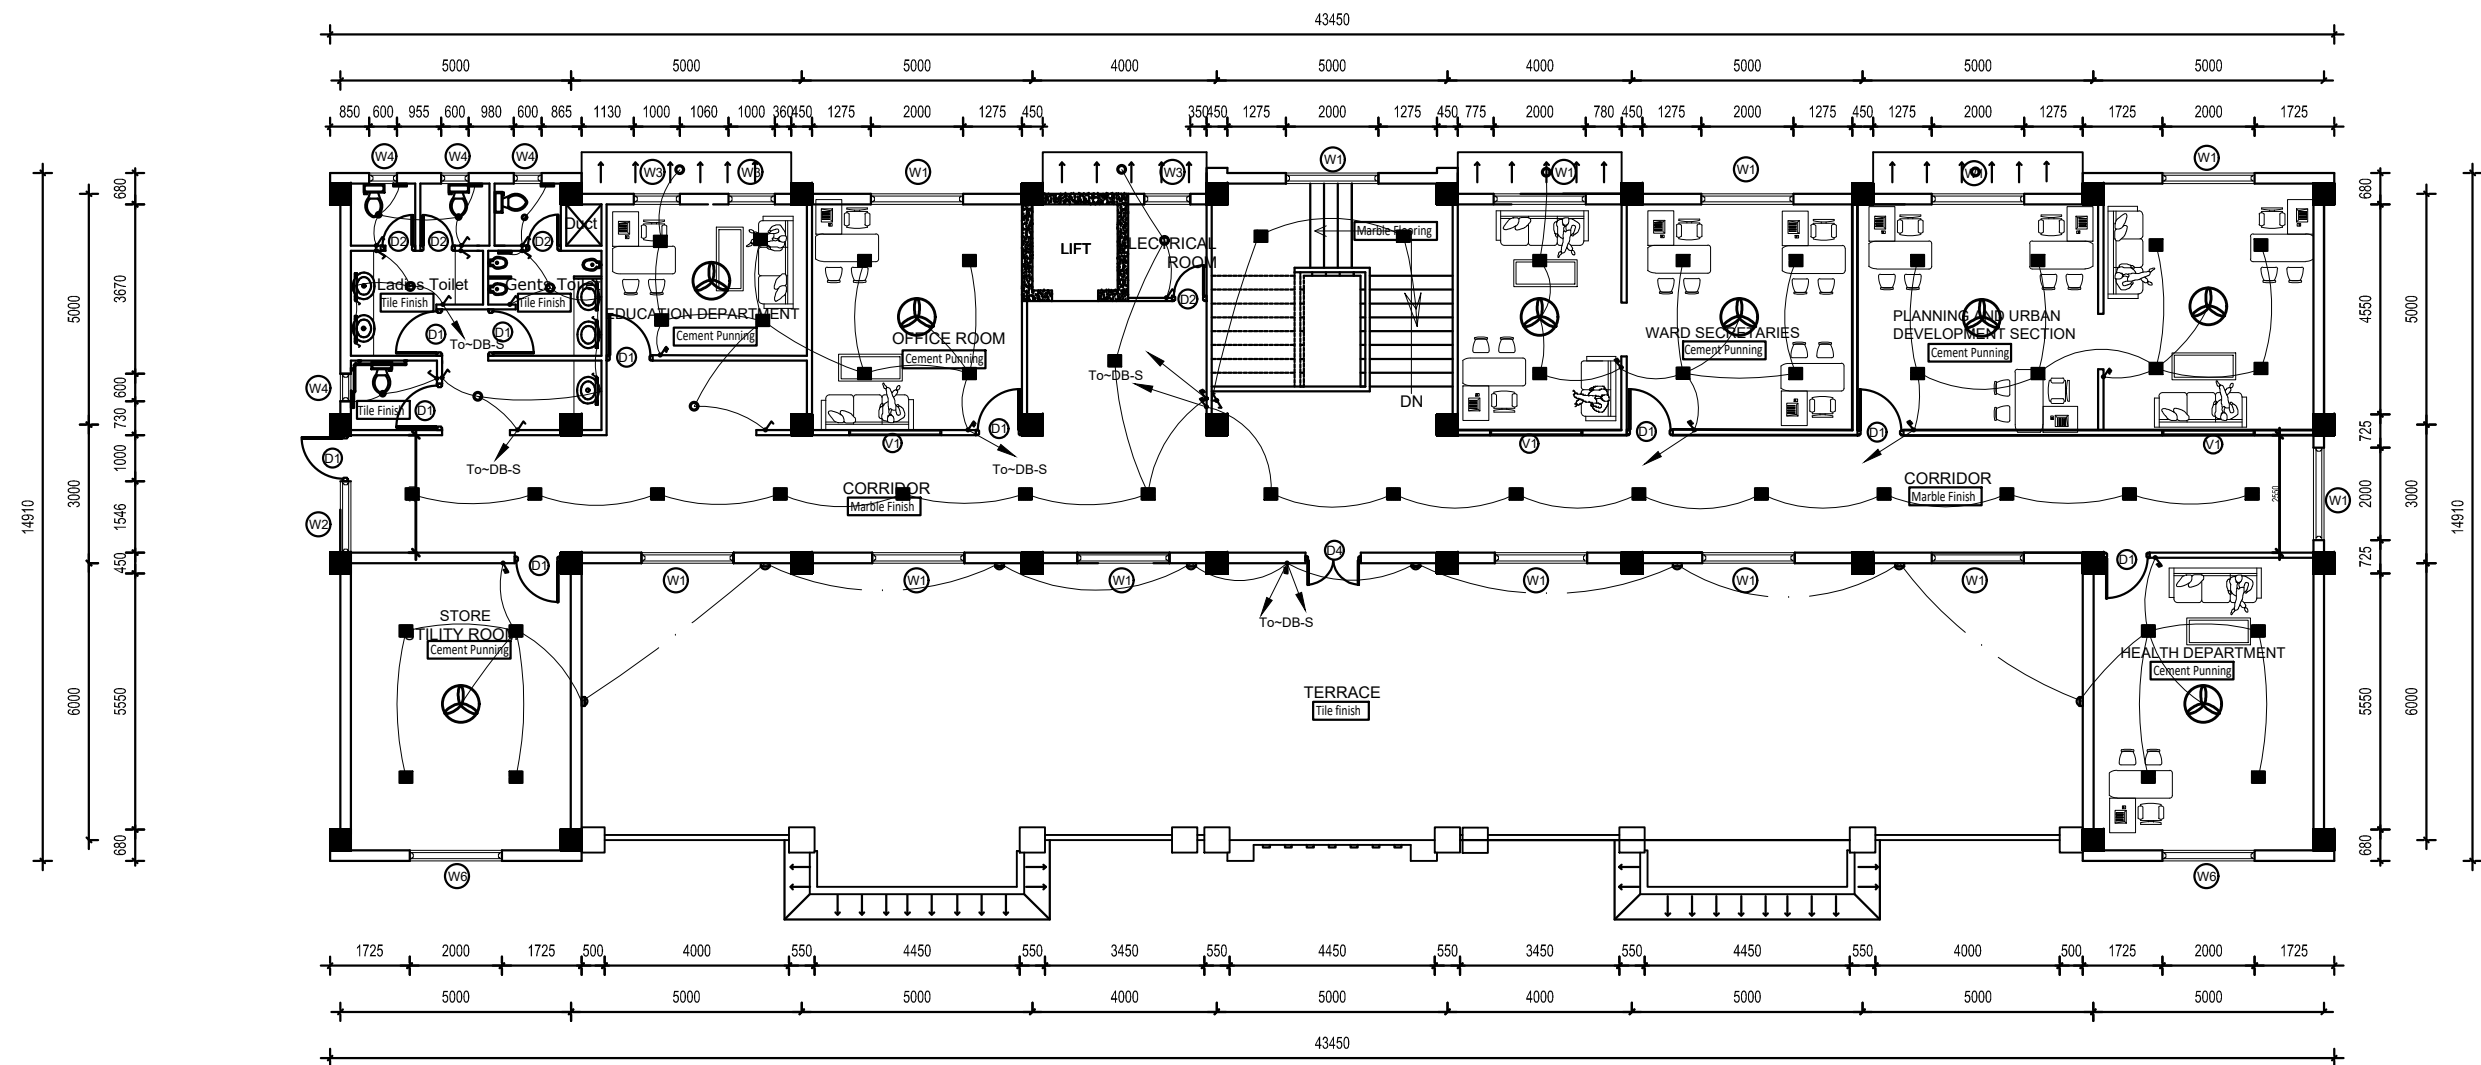

TOP FLOOR PLAN
Area: 421.20 SQ.M.

Client :
Rautamai Rural Municipality
Office of the Municipal Executive
Bhutar, Udaypur
Province-1
Nepal

Consultant :
Gaumukhi Engineering Services Pvt.Ltd
Sanepa,Lalitpur-2, Nepal
Phone: 01-5905005
Email: gaumukhiengineering@gmail.com

Project Title:
Detailed Project Report of Municipality Building
Rautamai Rural Municipality, Bhutar, Udaypur

Consultant:
Designed By :
Signature :
Checked By :Mahan Ji Yadev
Signature :
Approved By :
Signature :


Drawn By :

Client:
Checked By :
Signature :
Recommended By :
Signature :
Approved By :
Signature :


Sheet Title:
LIGHT LAYOUT PLAN OF
ROOF PLAN
Date :2019
Scale : 1:150
Unit :Millimeter

Sheet No. :

E
06

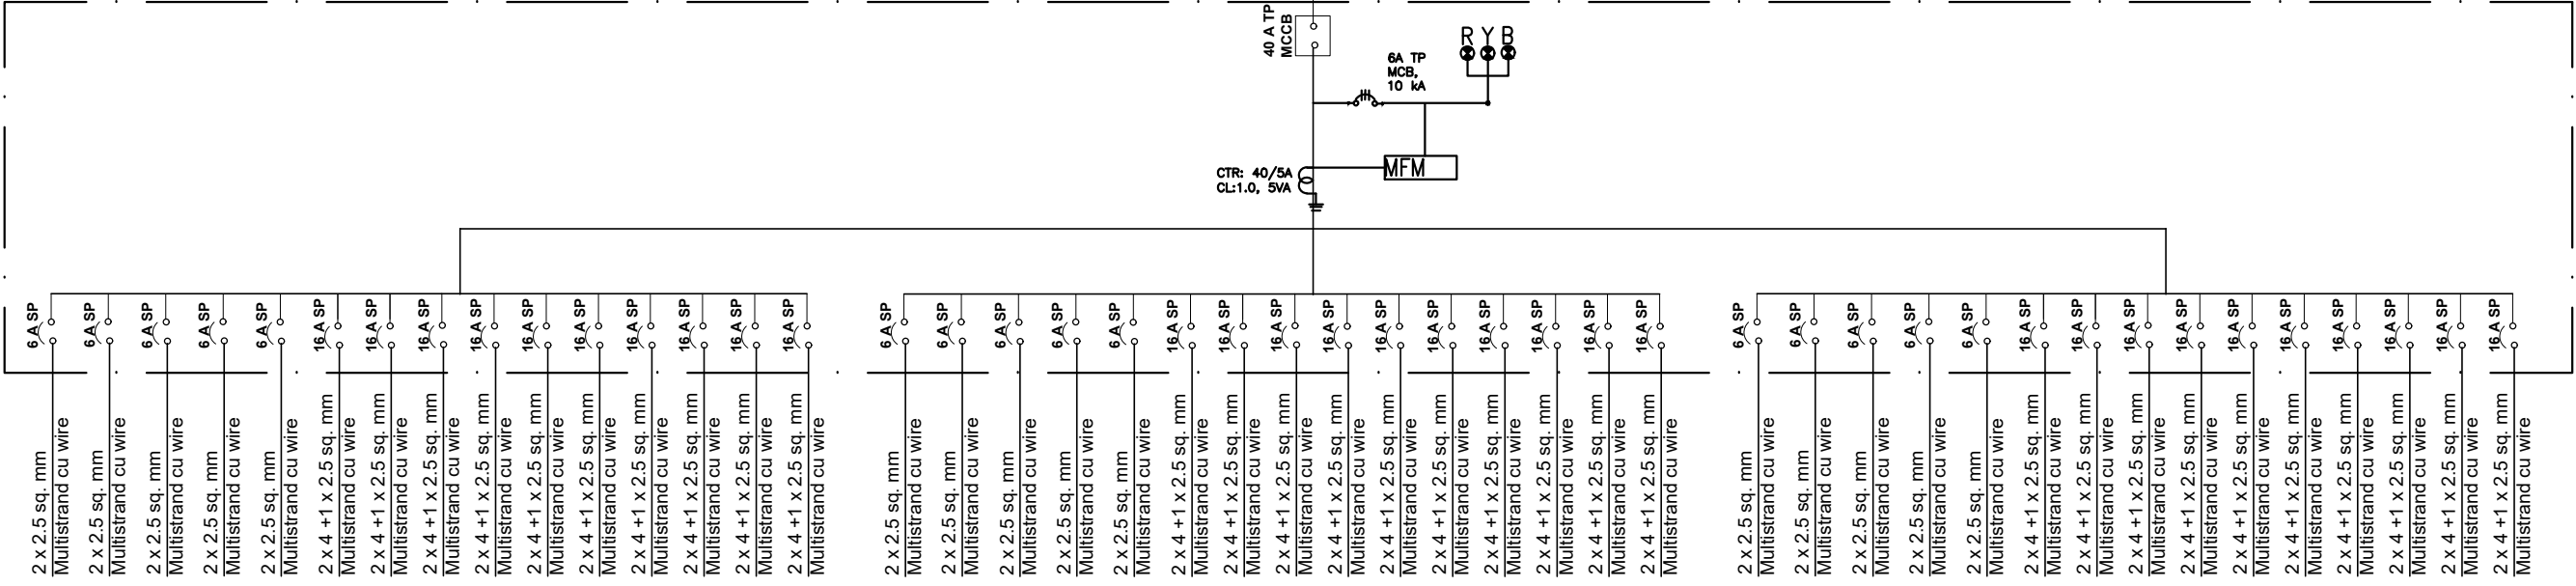

GROUND & FIRST FLOOR DB

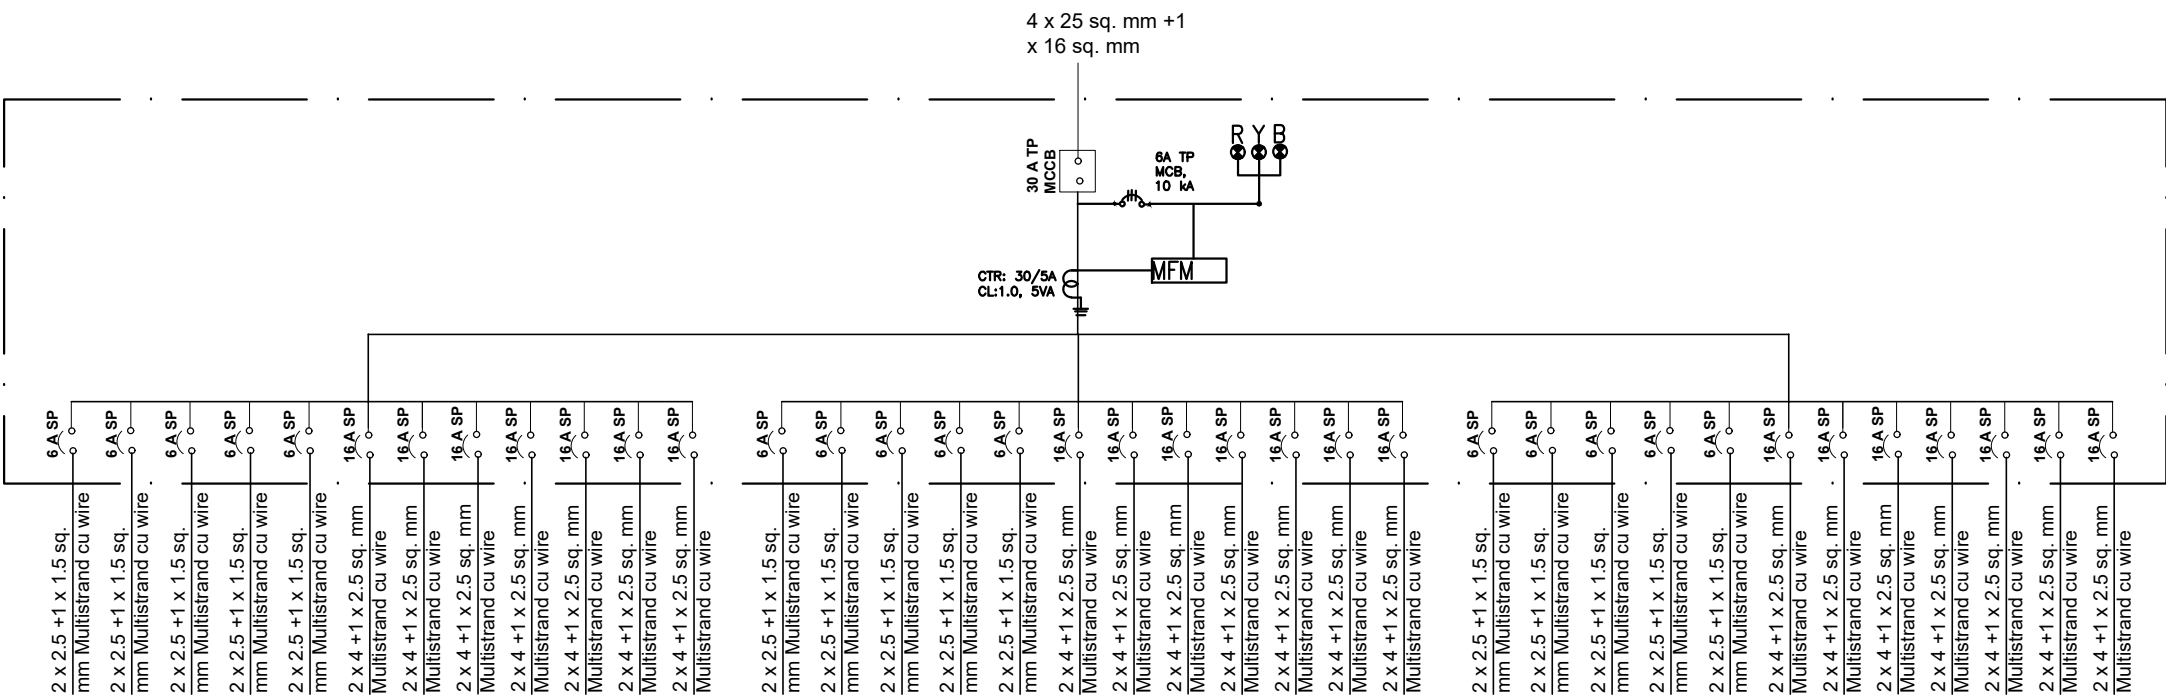

SECOND FLOOR DB

Client :
Rautamai Rural Municipality
Office of the Municipal Executive
Bhutar, Udaypur
Province-1
Nepal

Consultant :
Gaumukhi Engineering Services Pvt.Ltd
Sanepa,Lalitpur-2, Nepal
Phone: 01-5905005
Email: gaumukhiengineering@gmail.com


Project Title:
Detailed Project Report of Municipality Building
Rautamai Rural Municipality, Bhutar, Udaypur

Consultant:
Designed By :
Signature :
Checked By :Mahan Ji Yadev
Signature :
Approved By :
Signature :

Client:
Checked By :
Signature :
Recommended By :
Signature :
Approved By :
Signature :

Sheet Title:
DETAIL DRAWING
Date :2019
Scale : 1:150
Unit :Millimeter

Sheet No. :
E
07

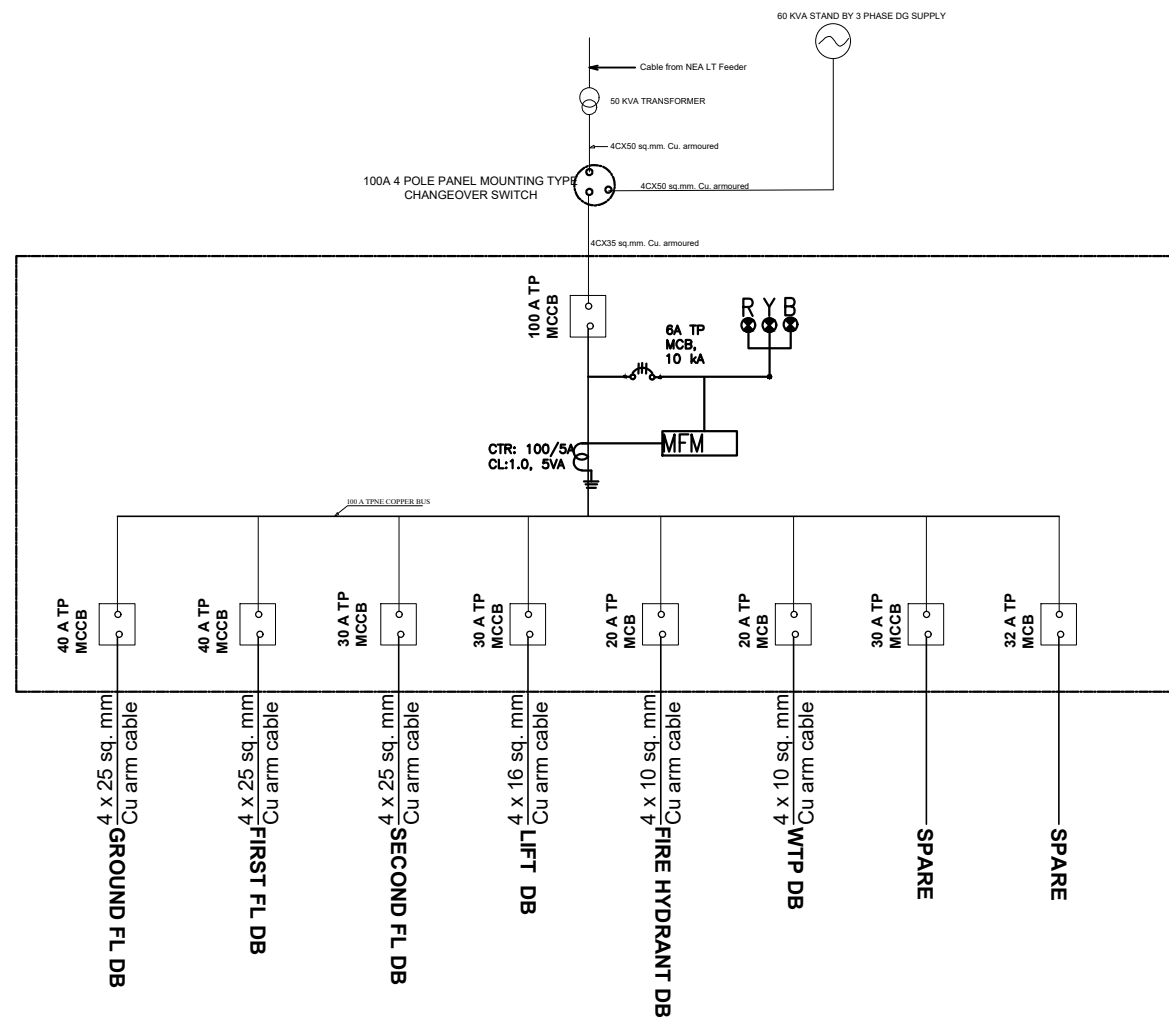


MAIN DB

LEGENDS


	Ceiling Rose
	4" dia concealed recessed downlighter with 6 W LED Light
	6" dia Rec/Surface down lighters with 9 W LED Light
	8" dia flat ceiling dome with 15 W LED Light
	8x5 W chandelier Light
	Wall lights with 1 x 11 W warmlight PL
	FootLight at ht of 2'6" ht with 4W warm color LED Light
	Bulkhead Light at ht of 7'2" ht with 1 x 11W warm color PLT
	X-Ray display Light
	Bathroom Mirror Light at 3" ht from top level of Mirror
	Recess/Surface Mounted 18 watt LED light
	Recess/Surface Mounted 36 watt LED light
	20 W LED BED HEAD LIGHT
	OT LIGHT
	15 W outdoor water proof light
	Exhaust Fan 9" dia
	20 W Box type LED Light

	42" dia ceiling fan
	1 Way Gang Light Switches
	2 Way Switches
	5 A, 2 pin socket at switch ht from FF
	15A, 3/16 pin socket at 15" (centre) ht from FF
	13/15A, 3/16 pin generator/UPS supply socket at 36" (centre) ht from FF
	20 A, Aircon power socket with starter at 7'6" ht from FF
	3 Phase Power socket (wall mounted)
	Bed Head Panel
	Sub Distribution Board (SDB)
	Distribution Board (DB)
	Main Control Panel
	Conduit Light & Fan Point-city supply
	Conduit Light & Fan Point- Generator supply
	Conduit Power Point-city supply
	Conduit Power Point- Generator supply
	Mains Cable

	Telephone point
	Earth Pit
	20 mm dia HDPE conduit with 3 pair telecom cable
	32 mm dia HDPE conduit with 2 x 20 pair communication cable
	TV point
	Low Voltage distribution Board
	20 mm dia HDPE conduit with TV coaxial cable
	LAN point
	20 mm dia HDPE conduit with CAT 6 cable
	Close Circuit Camera
	coaxial camera cable and 2 x 3/22 or twin RS cable for camera power in 20 mm dia conduit from the CCTV to the BOM/Monitor

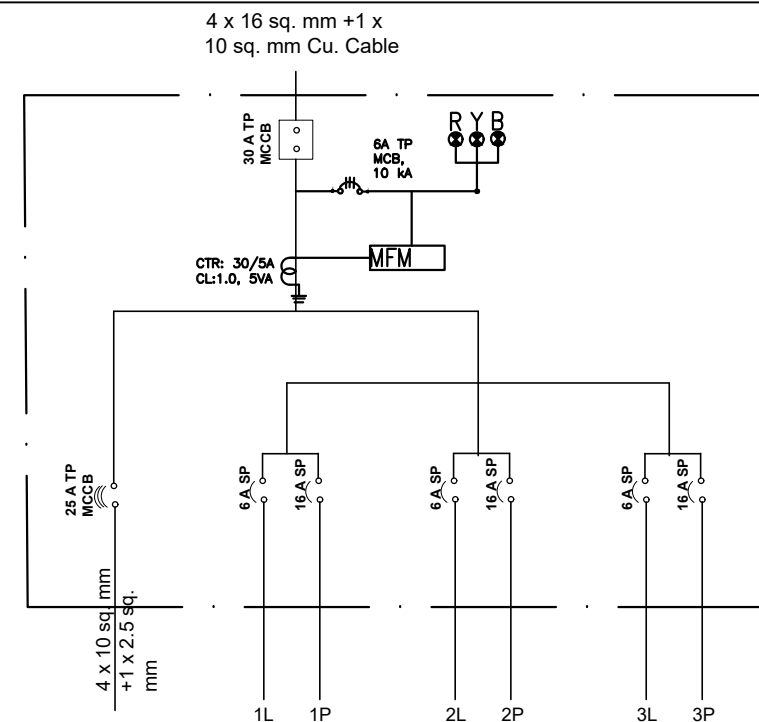

Lift - DB

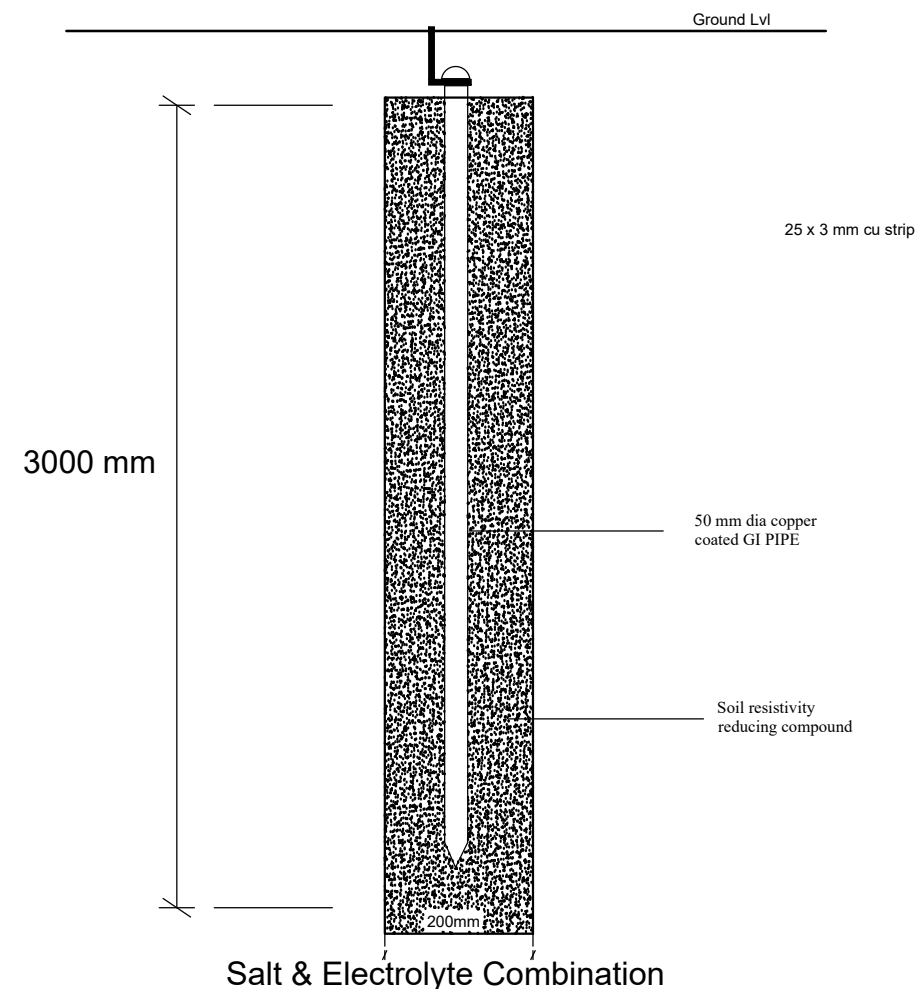

Client :
Rautamai Rural Municipality
Office of the Municipal Executive
Bhutar, Udaypur
Province-1
Nepal

Consultant :
Gaumukhi Engineering Services Pvt.Ltd
Sanepa,Lalitpur-2, Nepal
Phone: 01-5905005
Email: gaumukhiengineering@gmail.com

Project Title:
Detailed Project Report of Municipality Building
Rautamai Rural Municipality, Bhutar, Udaypur

Consultant:
Designed By :
Signature :
Checked By :Mahan Ji Yadev
Signature :
Approved By :
Signature :

Client:
Checked By :
Signature :
Recommended By :
Signature :
Approved By :
Signature :

Sheet Title:
DETAIL DRAWING
Date :2019
Scale : 1:150
Unit :Millimeter

Sheet No. :
E
08